

NOTES:

1. UNLESS OTHERWISE INDICATED, ALL WORKS TO BE DONE BY THE CONTRACTOR.
2. THE ELECTRICAL CONTRACTOR SHALL SUPPLY AND INSTALL ALL CABLE TRUNKINGS /CONDUITS. ALL WIRING FROM TELECOMS RISER TO EACH BLOCK TERMINAL/TEL. POINT ARE TO BE SUPPLY/INSTALL BY THE ELECTRICAL CONTRACTOR.
3. SINGAPORE TELECOMS ARE TO SUPPLY/INSTALL THE TEL. CABLES TO THE MDF. FROM MDF ROOM TO EACH INDIVIDUAL RISER. ALL DP SHALL BE LOCATED IN THE TEL RISER.
4. ALL EQUIPMENT & COMPONENTS USE FOR CATV SYSTEM SHALL BE SINGAPORE CABLE VISION (SCV) APPROVED TYPE.
5. ELECTRICAL CONTRACTOR SHALL ENGAGE A LICENSED REGISTERED CATV/SCV CONTRACTOR TO CARRY THE INSTALLATION WORKS.
6. ELECTRICAL CONTRACTOR SHALL PROVIDE A 2 METRES DROP CABLE FOR EACH TV OUTLET WITH F CONNECTORS AT BOTH ENDS.
7. CONTRACTOR SHALL ENSURE THAT THE SYSTEM OFFER SHALL ENSURE THAT THE SYSTEM OFFER SHALL FUNCTION SATISFACTORY TO THE REQUIREMENTS AS STATED IN THE SPECIFICATIONS.

LEGEND

- ▶

AMPLIFIER
- ⌋

REGAL N-WAYS SPLITTER
- ⊕

N-WAYS TAP UNIT
- TV OUTLET
- ⏏

⏏


⏏

BONDED TO EARTH SYSTEM
- ⏏

⏏

⏏

13A S.S.O (1 GANG METALCLAD)

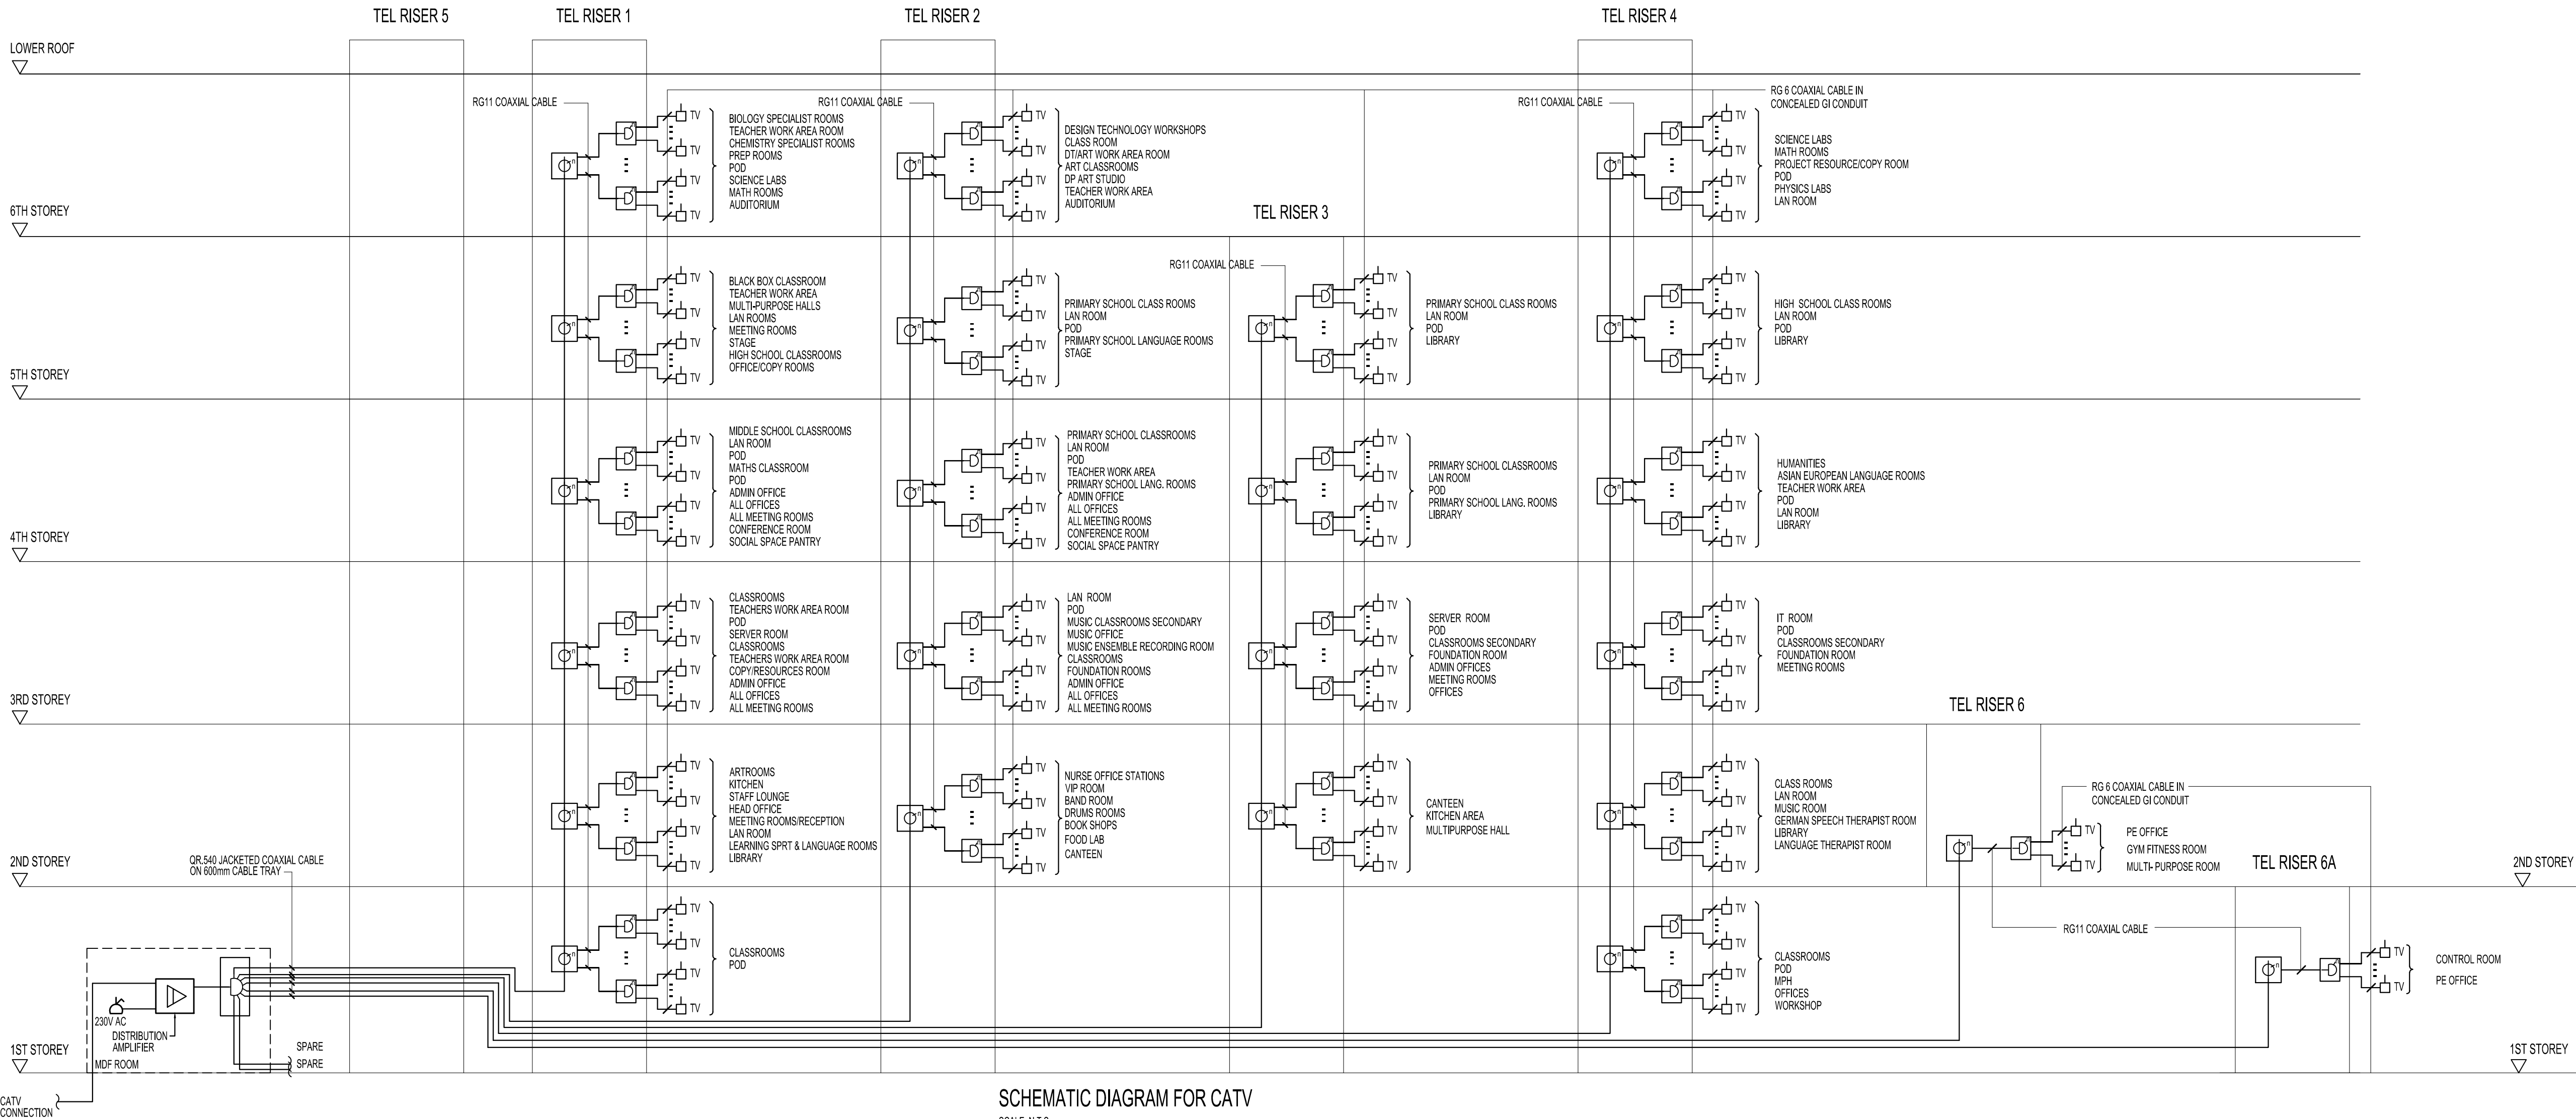

TENDER ADDENDUM NO. 7

DATE OF ISSUE

21 AUG 2015

BECA CARTER HOLLINGS & FERNER (S.E.A) PTE LTD

0E	FOR TENDER/ TENDER ADDENDUM NO. 7	AUG' 2015	MM1	KTEY
0C	FOR TENDER/ TENDER ADDENDUM NO. 3	AUG' 2015	MM1	KTEY
No.	Revision	Date	By	Chk

CLIENT :

GERMAN EUROPEAN SCHOOL SINGAPORE
(GESS)
72 Bukit Timah Road
Singapore 288760

TEL : 6465 1131
FAX : 6465 0308

ARCHITECT :

P&T CONSULTANTS PTE LTD
24 RAFFLES PLACE
#23-00 CLIFFORD CENTRE
SINGAPORE 048621
TEL : 6535 2011
FAX : 6535 1283

THE OWNERSHIP OF THE COPYRIGHT IN THIS DRAWING IS RETAINED BY P&T CONSULTANTS PTE LTD.
WHOSE CONSENT MUST BE SOUGHT BEFORE ANY USE OR REPRODUCTION OF THE DRAWING OR ANY
PART THEREOF CAN BE MADE.

M&E Engineer:

Beca

Beca Carter Hollings & Ferner
(S.E. Asia) Pte Ltd. Consulting Engineers
1 Gateway Drive, #12-01, Westgate Tower, Singapore 608531
Tel : 6220 7588 Fax : 6225 6937

Original Scale (A1)	Drawn Checked	MM1 KTEY	
Scale (A3) Reduced	Job Manager Job Director QP	LPH KBW DTSY	

Project:

PROPOSED ELECTRICAL SERVICES FOR
PROPOSED EDUCATIONAL INTUITION BUILDING COMPRISING
OF 6 STOREY EDUCATIONAL BLOCK, 2 STOREY AMENITIES
BLOCK WITH CARPARK AND COMMUNAL FACILITIES

Service:

ELECTRICAL SERVICES

Title:

CATV SCHEMATIC DIAGRAM

Drawing No.	Rev.
5810508/E-306	0